


UNIT ELECTRICAL SYMBOLS LIST:

- 120V., 15A., DUPLEX CONVENIENCE RECEPTACLE MTD. @+6" A.F.F. OR AS NOTED.
- 120V., 15A., DUPLEX RECEPTACLE, BOTTOM HALF SWITCHED FOR LIGHTING.
- 120V., 15A., DUPLEX CONVENIENCE RECEPTACLE MTD. @+6" ABOVE COUNTER OR SPLASH.
- 120V., 15A., G.F.I.-TYPE RECEPTACLE MTD. @+6" ABOVE COUNTER OR SPLASH.
- 120V., 15A., DUPLEX RECEPTACLE PROTECTED BY G.F.I. CRT. MTD. @+6" ABOVE COUNTER OR SPLASH.
- 120V., 15A., W.P. RECEPTACLE PROTECTED BY G.F.I. CRT. @+12" A.F.F..
- 120V., 20A., SINGLE RECEPTACLE MTD. IN UNDER-SINK SPACE, OR AS NOTED.
- 125/250V., 3P, 4W. GROUNDING-TYPE RECEPTACLE, 30A..
- 125/250V., 3P, 4W. GROUNDING-TYPE RECEPTACLE, 50A..
- TELEPHONE OUTLET BOX @+12 A.F.F..
- TELEVISION OUTLET BOX @+12 A.F.F..
- J-BOX FOR WALL MOUNTED INCANDESCENT FIXTURE. REFER TO ARCH'L DWG'S. FOR MTG. HEIGHT.
- J-BOX FOR SURFACE MTD. INCANDESCENT FIXTURE.
- RECESSED FIXTURE CAN WITH THERMAL PROTECTION, TRIM PER OWNER.
- PUSH BUTTON CONTROL DEVICE @+48" A.F.F..
- PHOTOCELL-TYPE SMOKE DETECTOR MTD. WITHIN 12" OF CEILING.
- OUTLET BOX FOR DOOR CHIME DEVICE MTD. WITHIN 12" OF CEILING.
- THERMOSTAT OUTLET BOX @+48".
- COMPUTER OUTLET BOX PROVIDE 1/2" C.O. TO PANEL 'A'

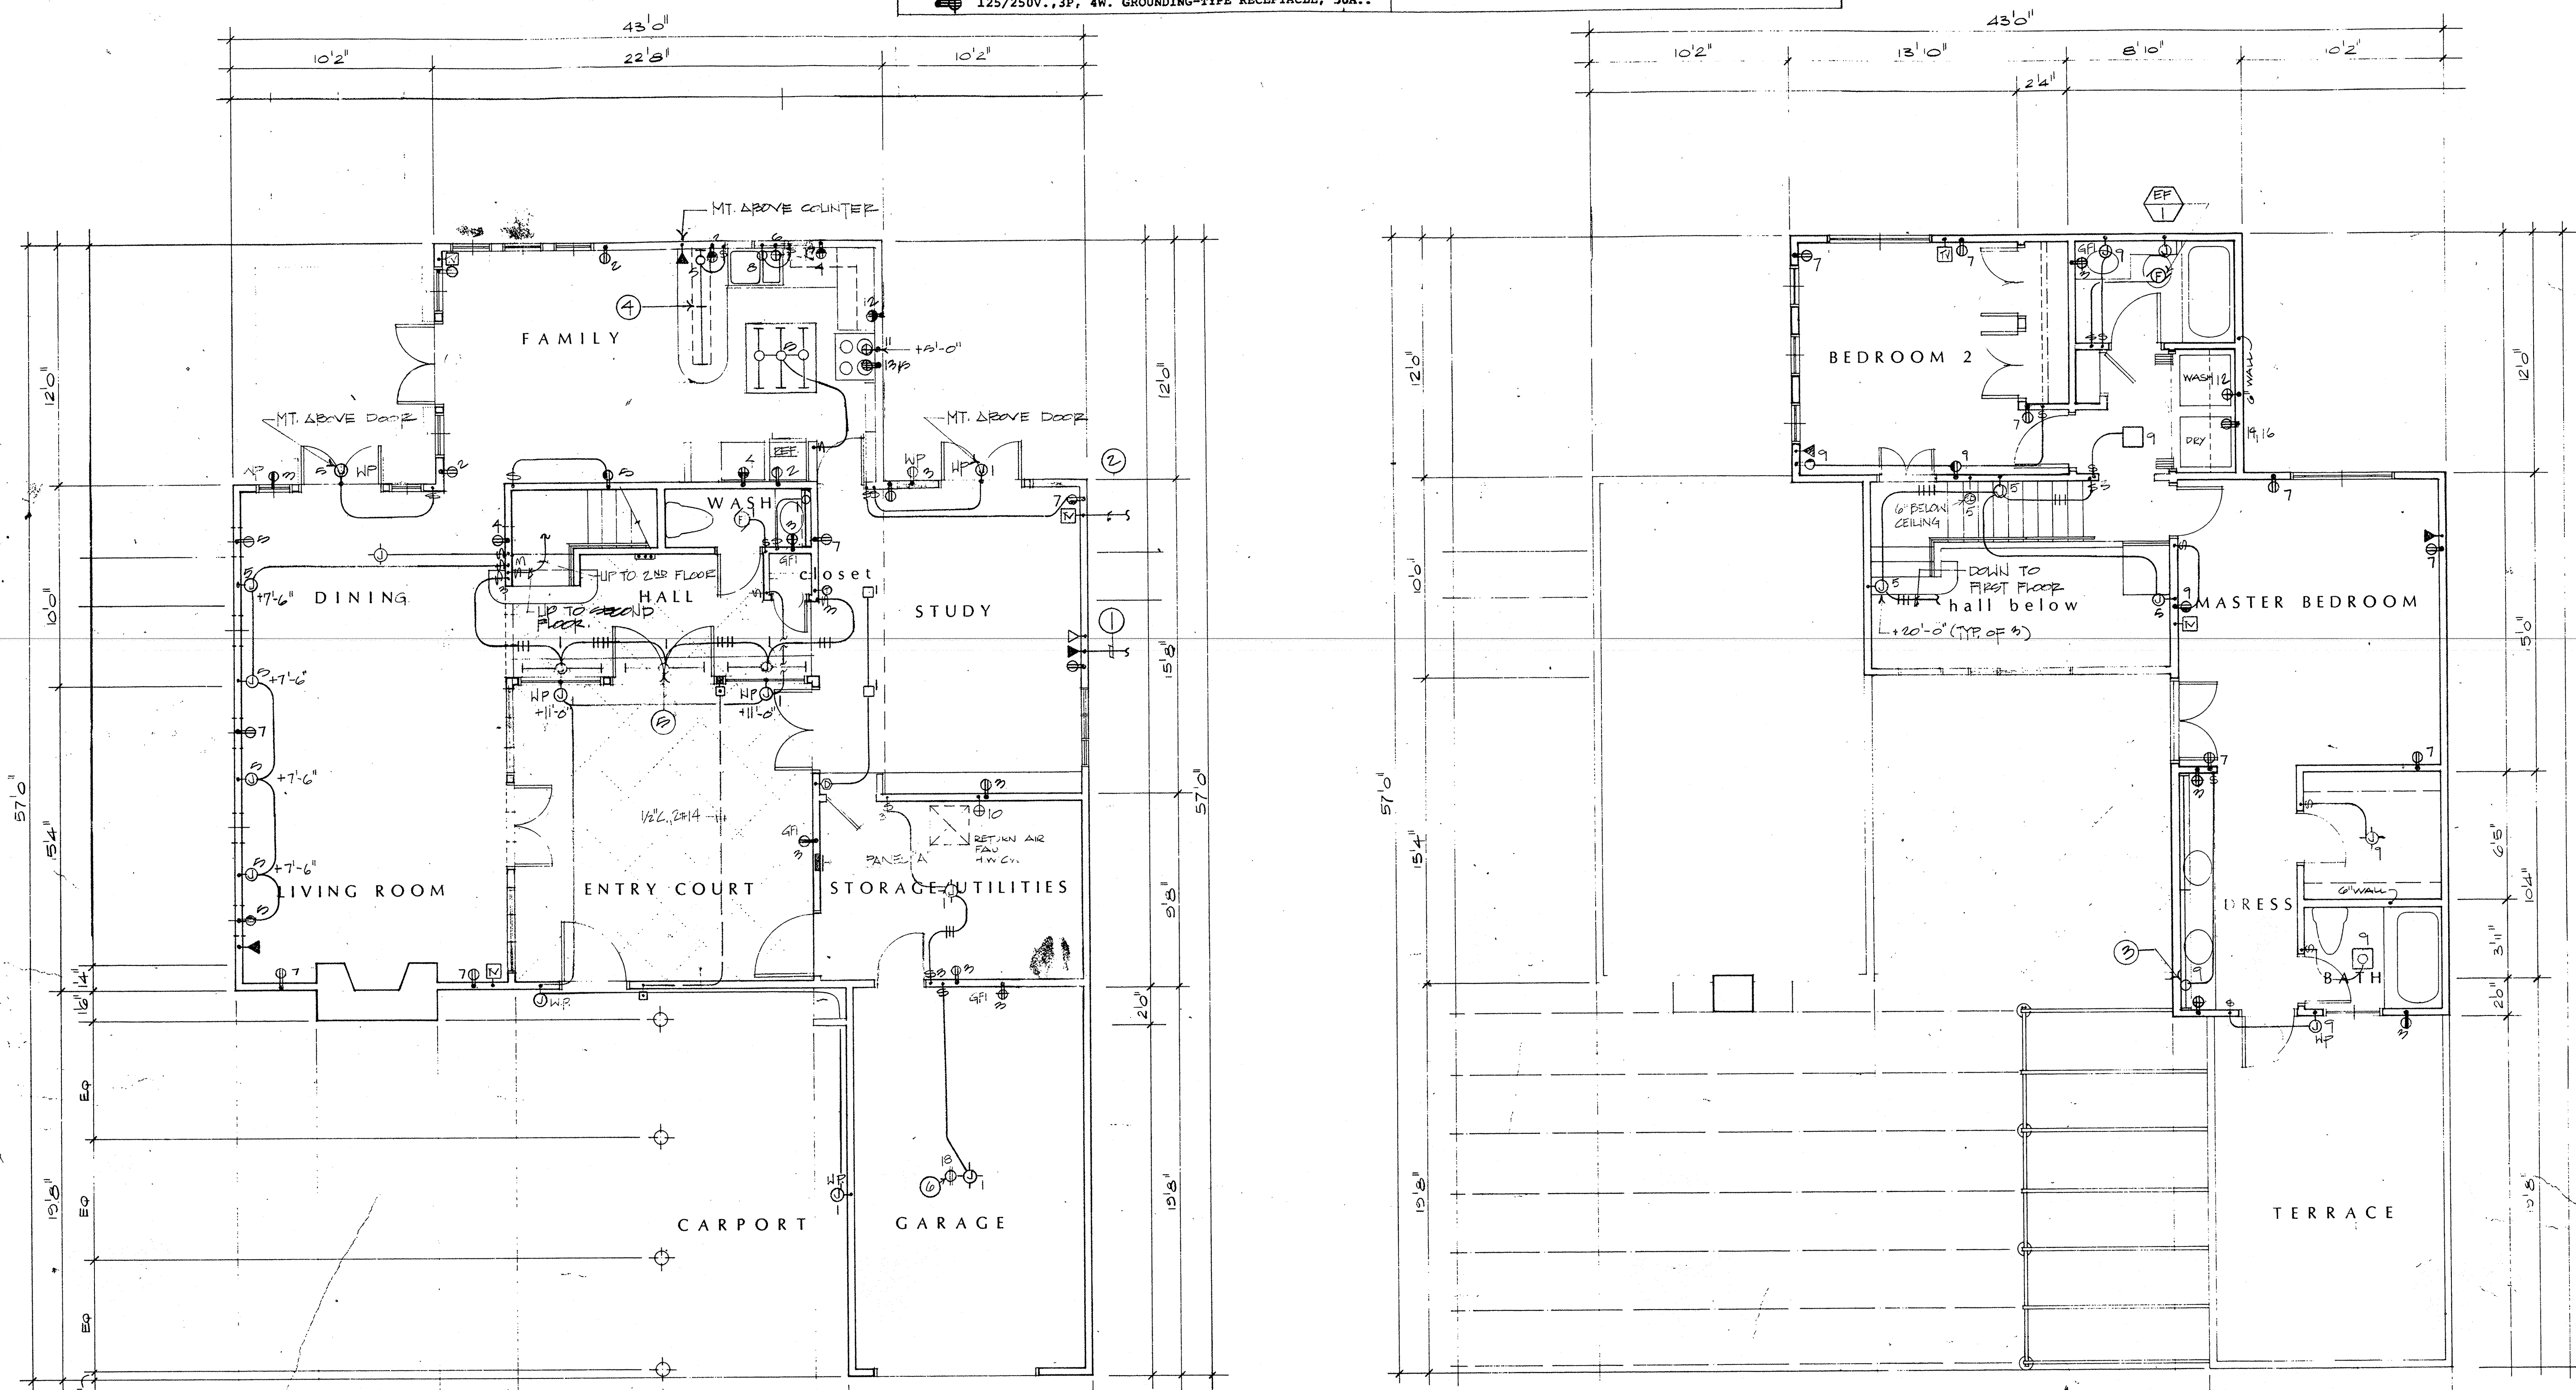

- ELECTRICAL PLAN NOTES:
- ① PROVIDES 1/2" C.O. TO TELEPHONE BACKBOARD FROM NEAREST OUTLET BOX. SEE SITE PLAN, SHEET E-1, AND DETAIL (A) FOR LOCATION.
  - ② SAME AS ① EXCEPT TELEVISION BACKBOARD.
  - ③ (2) - 11" x 10" LENGTH STAGGERED STRIP FLUORESC. FIXTURES MTD. BEHIND MIRROR. REFER TO DETAIL (B).
  - ④ FLUORESCENT FIXTURE SURFACE MTD. UNDER CABINET.
  - ⑤ FLUORESCENT FIXTURE SURFACE MTD. ABOVE LEDGE. SEE (C).
  - ⑥ RECEPTACLE MOUNTED ON CEILING FOR GARAGE DOOR OPENER.

FIRST FLOOR ELECTRICAL PLAN  
SCALE: 1/4" = 1'-0"

SECOND FLOOR ELECTRICAL PLAN  
SCALE: 1/4" = 1'-0"

no.	date	by
revision		
<b>IBI</b>		
Group		
Architects and Planners		L. Paul Zajfen
consultants		
<b>RWR</b>		
CONSULTING ELECTRICAL ENGINEERS		
ASSOCIATES		
2000 ARDEN AVENUE, SUITE 204 • COSTA MESA, CA 92626		
714/537-8071		
85.40.1015		
project title		

U.C.S.B.

sheet title	
UNIT 1	
ELECTRICAL	
FLOOR PLAN	
scale	date
1/4" = 1'-0"	
drawn	checked
J.P.B.	J.P.B.
project no.	sheet no.
106	E-2

AS BUILT  
WALTON ELECTRIC CORP.  
P.O. Box 1856  
321 S. Vermont  
Glendora, CA 91740

This drawing as an instrument of service, is the property of the architect and may not be reproduced without their permission and unless the reproduction carries their name. All designs and other information shown on this drawing are to be used on the specified project only and shall not be used otherwise without written permission of the architect.

Written dimensions shall have precedence over scale dimensions. Contractors shall verify and be responsible for all dimensions and positions of the field and the architect shall be informed of any variations from the dimensions and conditions shown on the drawing. Shop drawings shall be submitted to the architect for approval before proceeding with fabrication.