


FIRST FLOOR

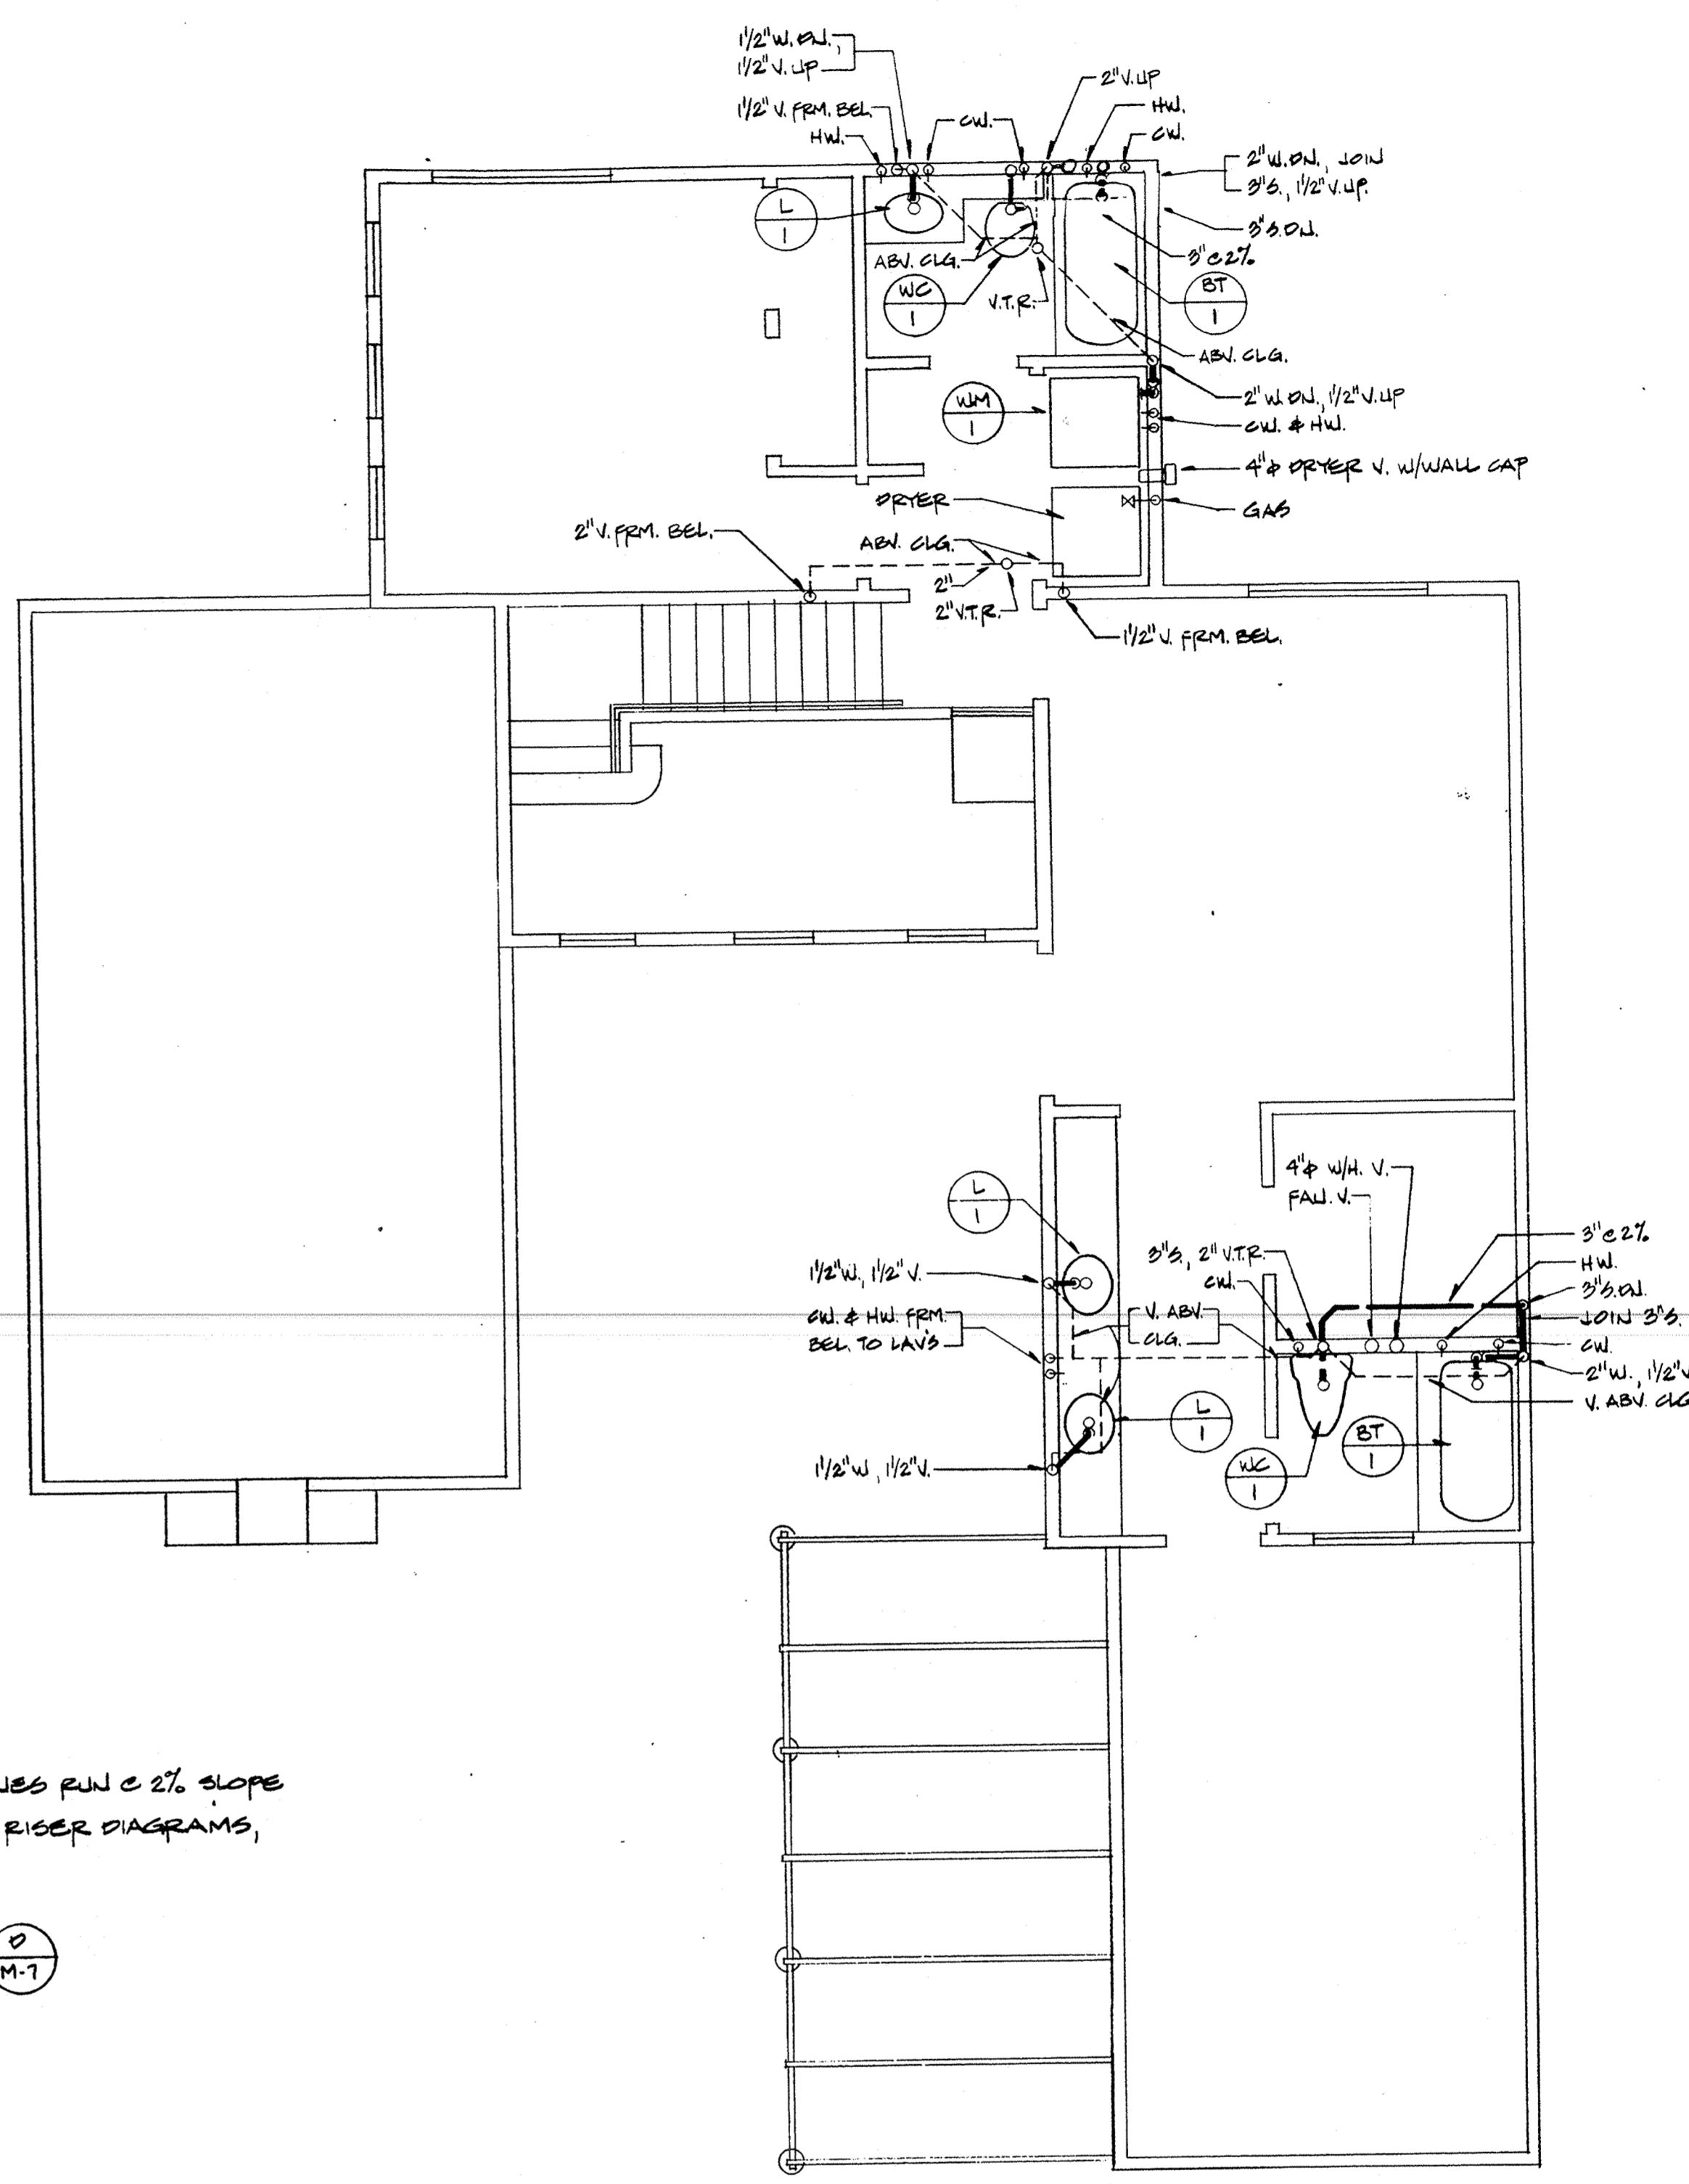

SECOND FLOOR

UNIT #1 PLUMBING FLOOR PLANS
SCALE = 1/4" = 1'-0"

- NOTE:
- 1) ALL SOIL & WASTE LINES RUN @ 2% SLOPE
 - 2) FOR PIPE SIZES SEE RISER DIAGRAMS, SET. (A) (B) (C) (M-7)
 - 3) FOR SOLAR, SEE SET. (D) (M-7)

MAY 18 1987
R. P. RICHARDS

AS BUILT
DRAWINGS

no.	date	by

BI
Group
Architects and Planners
L. Paul Zajten
358 San Miguel Drive
Suite 200
Newport Beach, California
92660
(714) 644-4091

project title

sheet title
UNIT #1 PLUMBING
FLOOR PLANS

scale 1/4" = 1'-0"	date
drawn S.S.	checked C.W.E.
project no.	sheet no. M-2

This drawing, as an instrument of service, is the property of the architects and may not be reproduced without their permission and unless the reproduction carries their name. All designs and other information shown on this drawing are for use on the specified project only and shall not be used otherwise without written permission of the architects.

Written dimensions shall have precedence over scaled dimensions. Contractors shall verify and be responsible for all dimensions and conditions on the job and the architects shall be informed of any variations from the dimensions and conditions shown on the drawing. Shop drawings shall be submitted to the architects for approval before proceeding with fabrication.