


FIRST FLOOR

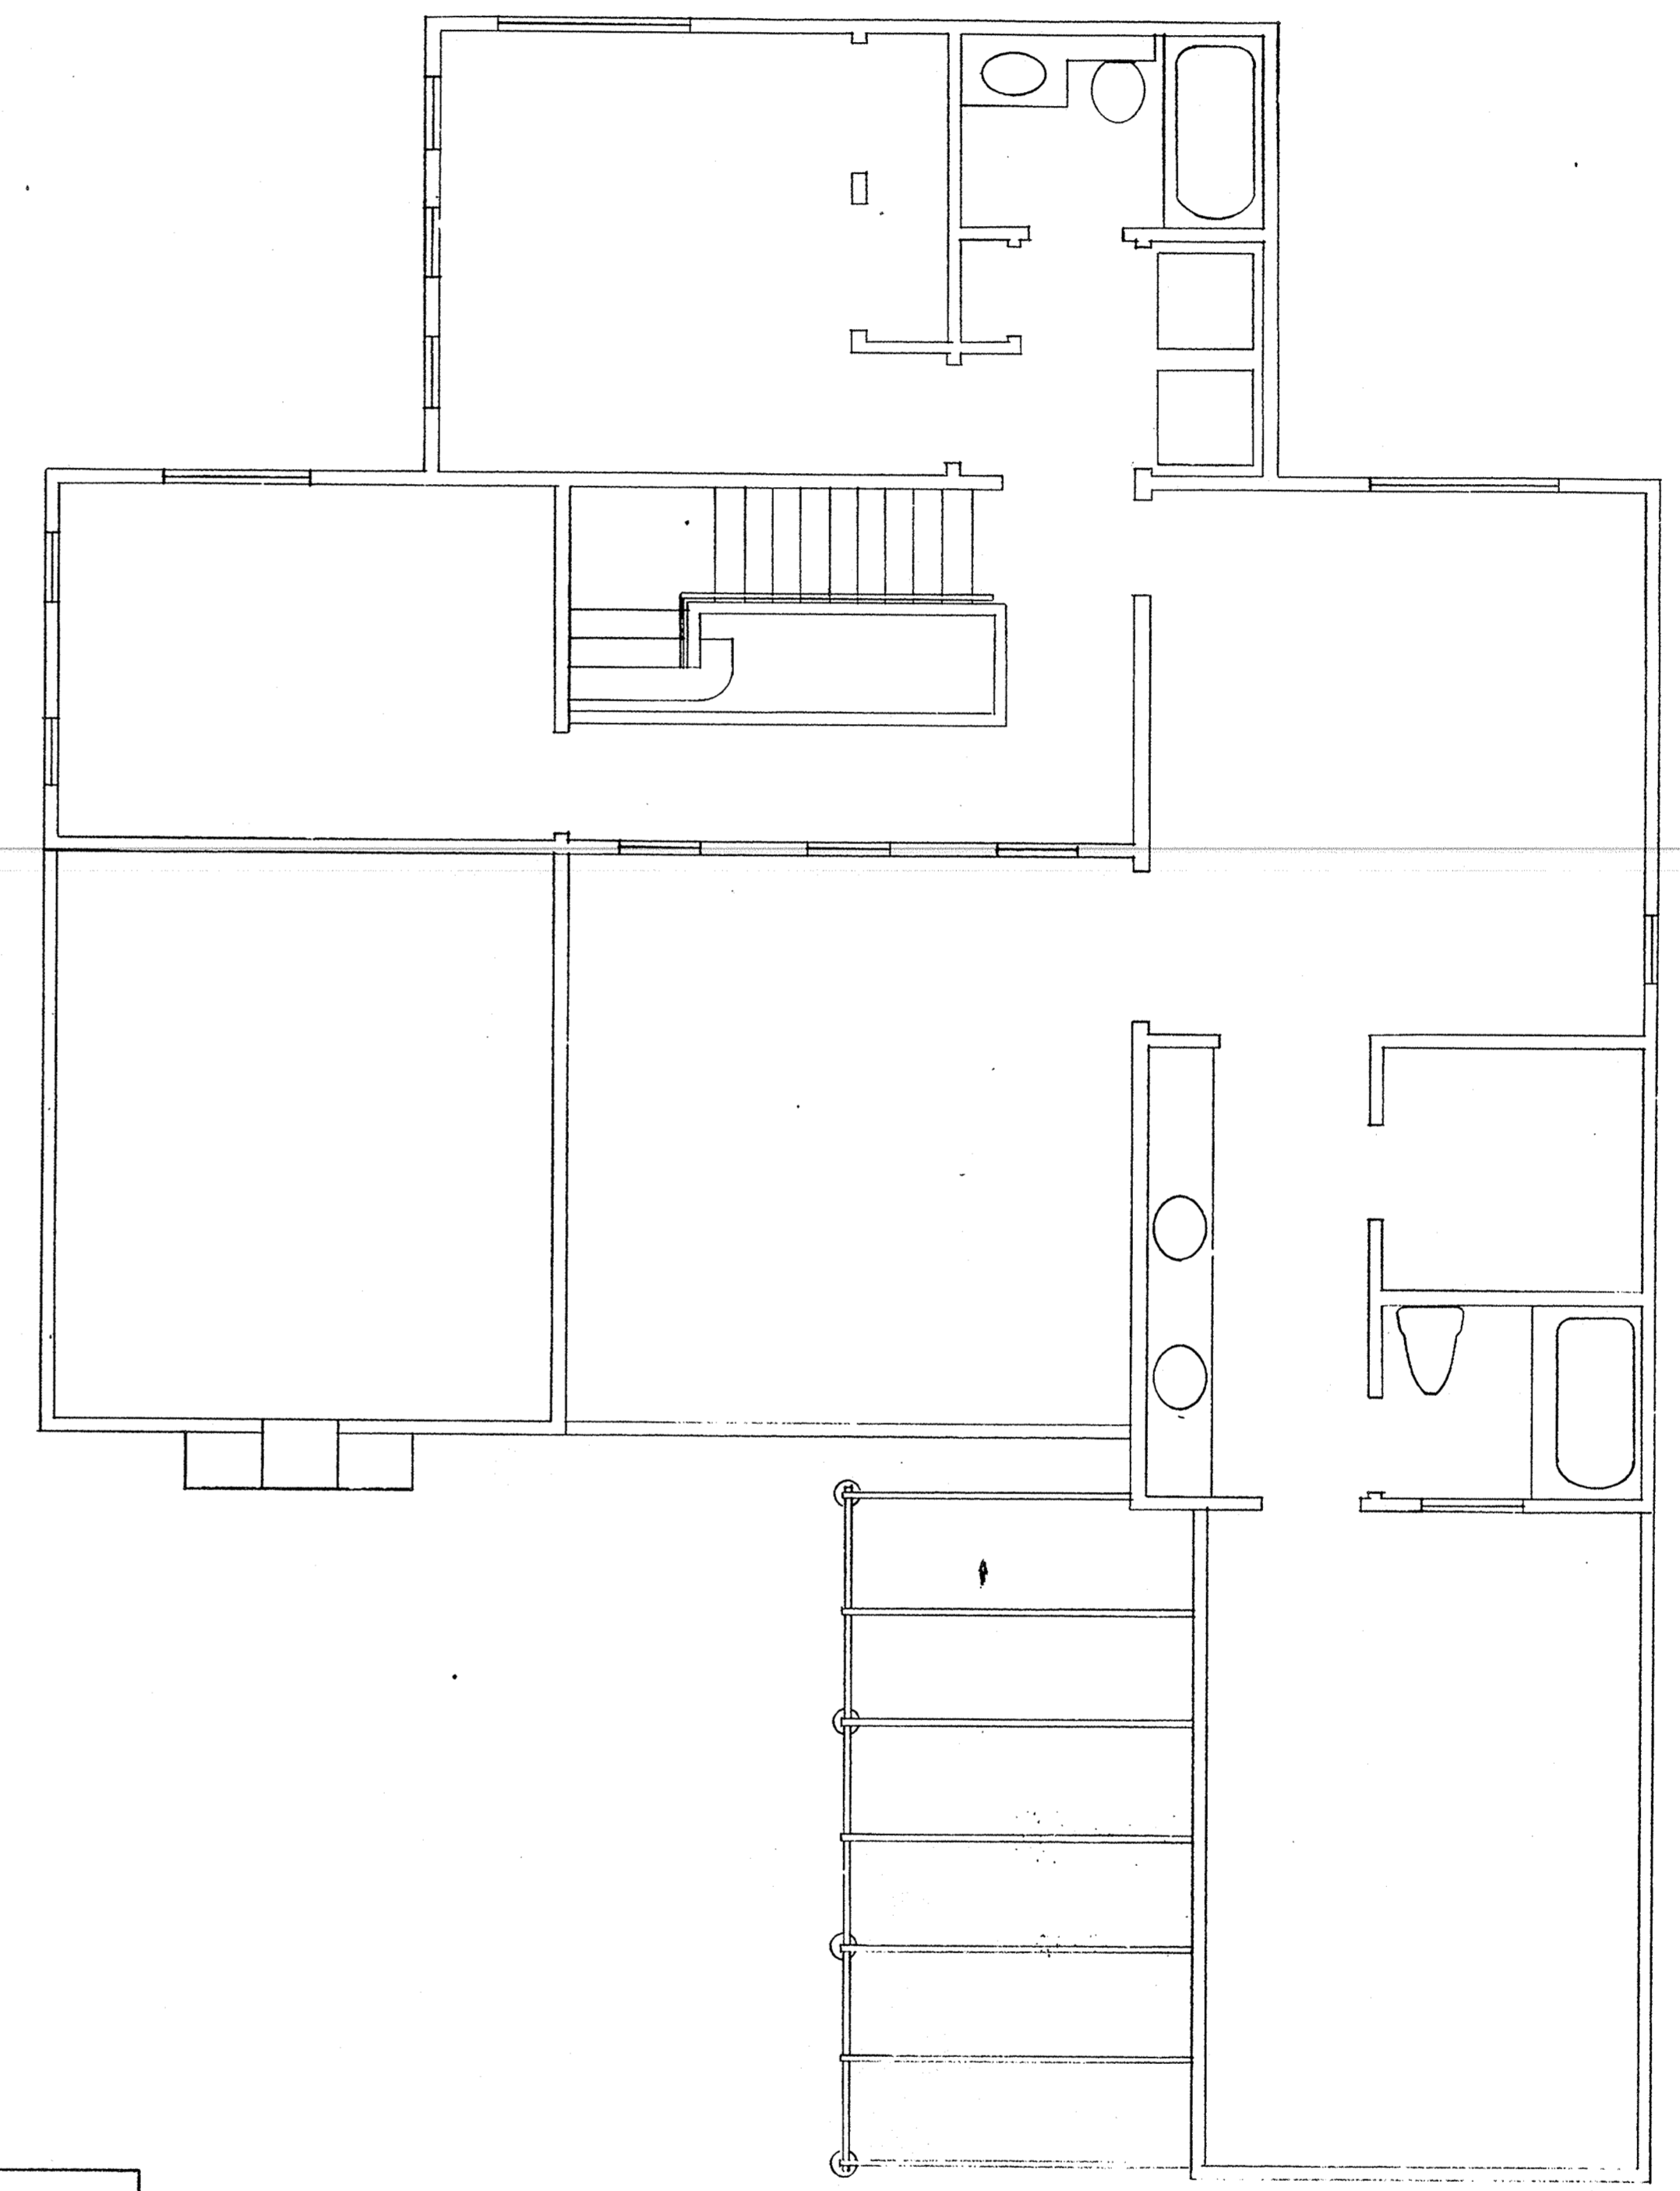

SECOND FLOOR

NOTE:
FIXTURES & PIPING TO FIXTURES
IDENTICAL TO UNIT #1, SHT. M-2

UNIT #2 PLUMBING FLOOR PLANS
SCALE 1/4" = 1'-0"

no.	date	by
revision		

IBI
Group
Architects and Planners
L. Paul Zeffen
359 San Miguel Drive
Suite 200
Newport Beach, California
92660
(714) 644-4091

consultants

project title

sheet title
UNIT #2 PLUMBING
FLOOR PLANS

scale	1/4" = 1'-0"	date	
drawn	G.S.	checked	S.W.E.
project no.		sheet no.	M-3

This drawing as an instrument of service is the property of the architects and may not be reproduced without their permission and unless the reproduction carries their name. All designs and other information shown on this drawing are for use on the specified project only and shall not be used otherwise without written permission of the architects.

Written dimensions shall have precedence over scaled dimensions. Contractors shall verify and be responsible for all dimensions and conditions on the job and the architects shall be informed of any variations from the dimensions and conditions shown on the drawing. Shop drawings shall be submitted to the architects for approval before proceeding with fabrication.